


RenderViewpoint\_1

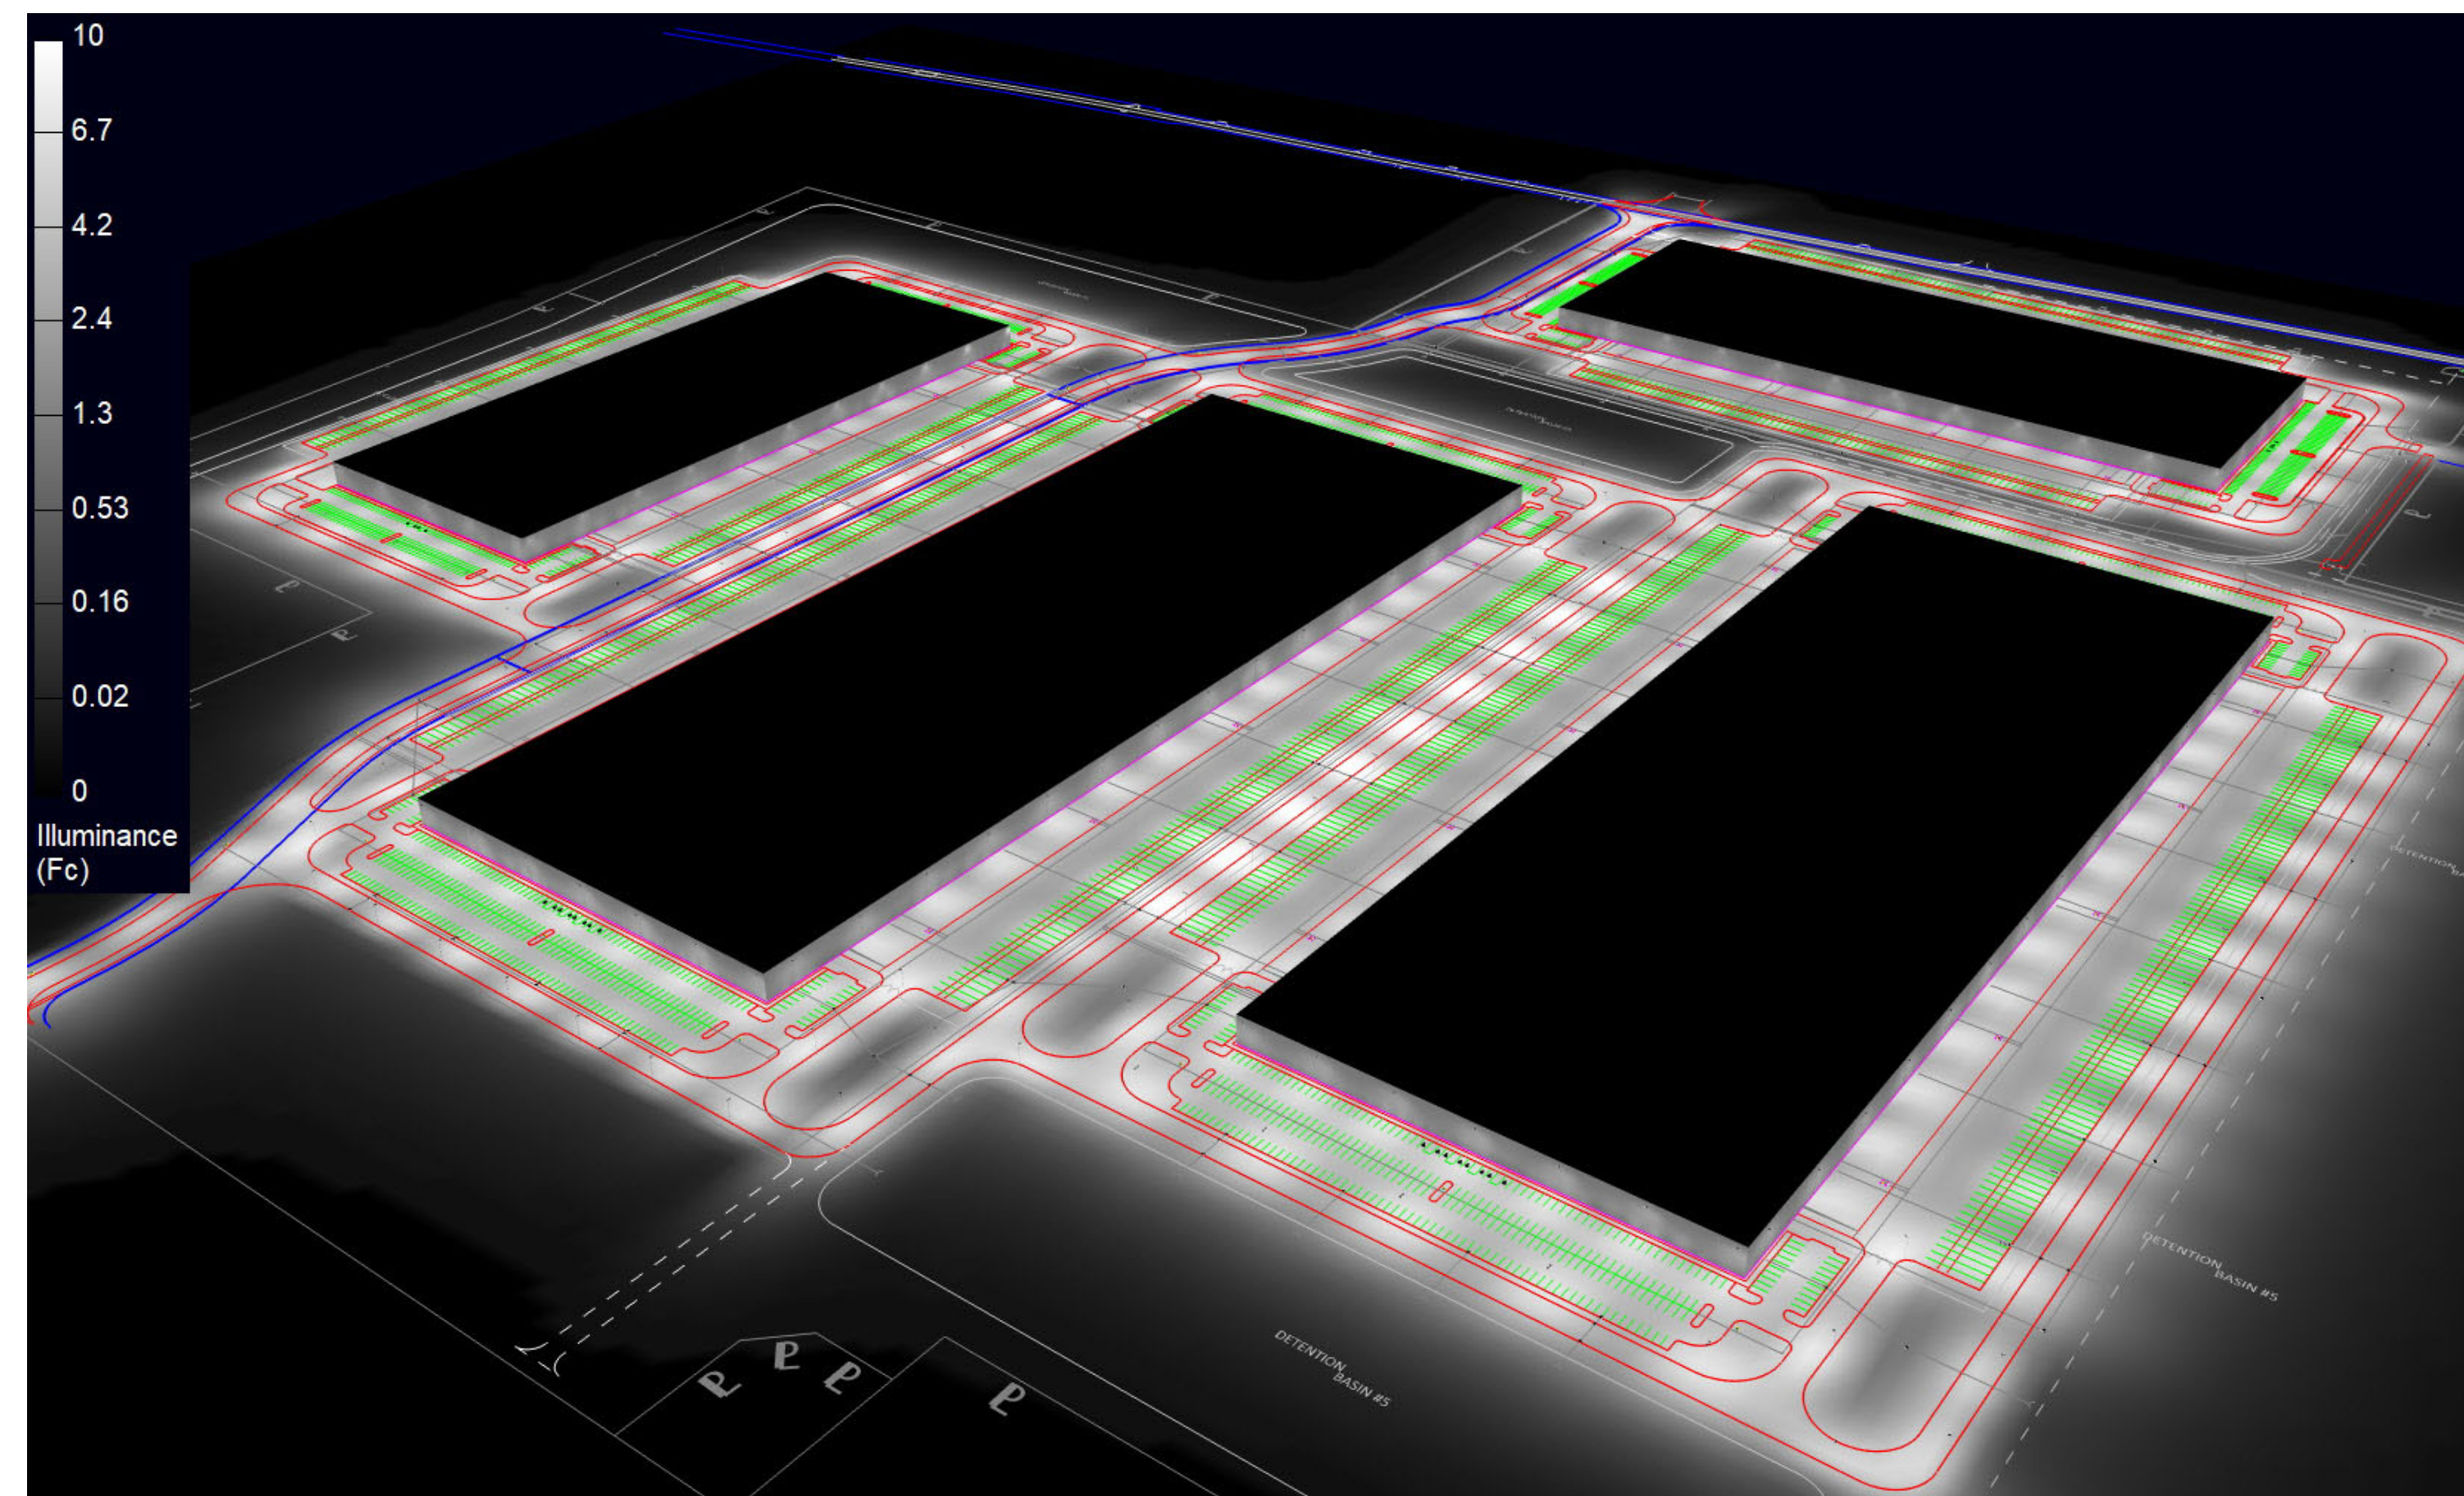

RenderViewpoint\_2

The Lighting Analysis, System Energy Analysis and/or Visual Simulation ("Lighting Design") provided by RAB Lighting Inc. ("RAB") represents an anticipated prediction of lighting system performance based on design parameters and information supplied by others. These design parameters and information have not been field verified by RAB and therefore actual measured results may vary from the actual field conditions. RAB warrants that design parameters and other information be field verified to reduce variation. RAB neither warrants, either implied or stated with regard to actual measured light levels or energy consumption levels as compared to those illustrated by the Lighting Design. RAB neither warrants, either implied or stated, nor represents the appropriateness, completeness or suitability of the Lighting Design as compliant with any applicable regulatory code requirements, unless specifically stated in writing on documents submitted by RAB. The Lighting Design is issued, in whole or in part, as advisory documents for informational purposes and is not intended for construction nor as being part of a project's construction documentation package.

Scale: as noted	PROJECT # 192304
Date: 4/21/2022	CASE # 00844890
Filename: DHL - Ashville PH2 Version A	Filename: DHL - Ashville PH2 00844890A.AGI
Drawn By: Donald G. Andrews	

Job Name:  
DHL - Ashville PH2  
Ashville, OH  
Lighting Layout  
Version A

Prepared For:  
Pollart Electrical Sales Inc.  
1231 Ford Road  
Bensalem, PA 19020  
Tel: 888-839-1591

**RAB**  
170 Ludlow Avenue, Northvale, NJ 07647  
888-722-1000 • rablighting.com